
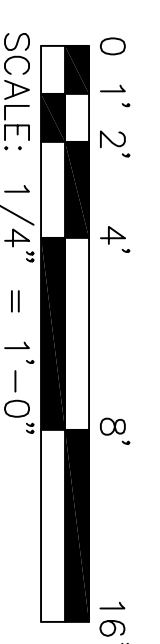


1 PLAN: DATA CENTER LAB FACILITY / ROOM 1470  
 HORIZONTAL SCALE: 1/4" = 1'-0"

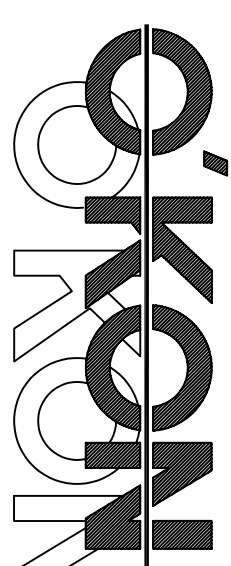

<p><b>G.W. WOODRUFF</b>          SCHOOL OF MECHANICAL ENGINEERING          THE GEORGE-INSTITUTE          OF TECHNOLOGY</p>	<p><b>PROJECT</b>          CETHERM LAB          575, 14TH STREET          ATLANTA, GEORGIA 30332-0620</p>	 OKON & COMPANY, INC. <small>Engineers/Architects          26-10 WOODRUFF AVENUE          ATLANTA, GEORGIA 30328 USA          E-MAIL: TEL: 404-527-2018          FAX: 404-542-0842</small>
<p><b>DRAWING TITLE:</b>          FLOOR PLAN:          NEW DATA CENTER LAB          ROOM 1470</p>		
<p><b>SCALE:</b> 1/4" = 1'-0"  <b>DRAWING NUMBER</b> A-102</p>		