



1 PLAN: SUPPORT LEVEL FOR HVAC / CEILING SYSTEMS (DATA CENTER)
 HATCHING SCALE: 1/4" = 1'-0"

EXISTING SLAB ON GRADE EL. +2'-0"

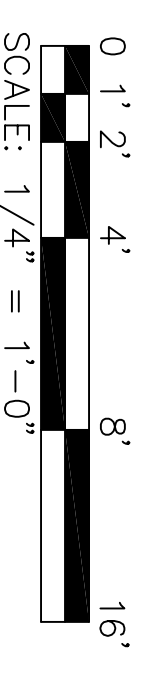

G.W. WOODRUFF
 SCHOOL OF MECHANICAL ENGINEERING
 THE GEORGE-INSTITUTE
 OF TECHNOLOGY

PROJECT
 CEETHERM LAB
 575, 14TH STREET
 ATLANTA, GEORGIA 30332-0620

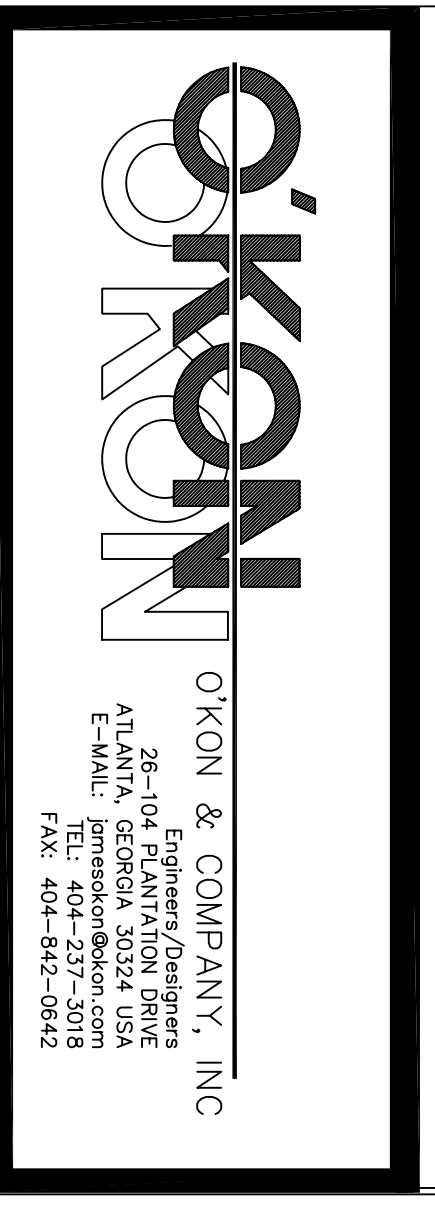

DRAWING TITLE:
 FLOOR PLAN:
 SUPPORT LEVEL PLAN
 ROOM 1470

SCALE: 1/4" = 1'-0"

DRAWING NUMBER A-103