
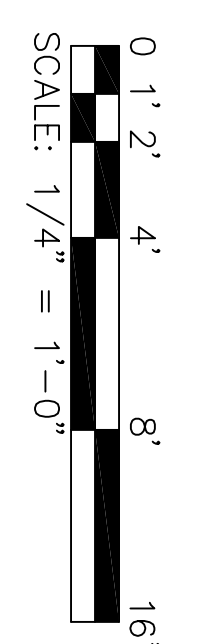


**NOTE: SEE MECHANICAL DRAWINGS FOR HVAC GRILL LOCATION.
SEE ELECTRICAL DRAWINGS FOR LIGHTING AND POWER LOCATIONS.**

1 REFLECTED CEILING PLAN
SCALE: 1/4" = 1'-0"

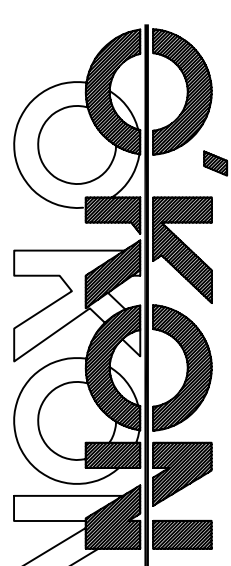

<p>G.W. WOODRUFF SCHOOL OF MECHANICAL ENGINEERING OF THE GEORGE-INSTITUTE OF TECHNOLOGY</p>
<p>PROJECT CEETHERM LAB 575, 14TH STREET ATLANTA, GEORGIA 30332-0620</p>
 <p>OKON & COMPANY, INC Engineers/Architects 26-10 WOODRUFF AVENUE ATLANTA, GEORGIA 30328 USA E-MAIL: INFO@OKON.COM TEL: 404-527-2018 FAX: 404-542-0842</p>
<p>DRAWING TITLE: REFLECTED CEILING PLAN:</p>
<p>SCALE: 1/4" = 1'-0" DRAWING NUMBER A-104</p>