

REVISIONS		
NO.	DATE	DESCRIPTION
1		ISSUED FOR CONSTRUCTION
2		ISSUED FOR CONSTRUCTION
3		ISSUED FOR CONSTRUCTION
4		ISSUED FOR CONSTRUCTION
5		ISSUED FOR CONSTRUCTION
6		ISSUED FOR CONSTRUCTION
7		ISSUED FOR CONSTRUCTION
8		ISSUED FOR CONSTRUCTION
9		ISSUED FOR CONSTRUCTION
10		ISSUED FOR CONSTRUCTION

McKenney's
Mechanical Contractors



1056 Moreland Ind. Blvd.
Atlanta, Ga. 30316-3296
(404) 622-5000

This drawing is the property of McKenney's, Inc. and is not to be reproduced or copied in any form without the written consent of McKenney's, Inc. It is to be used only for the project herein and is not to be used for any other project. It is to be returned upon request.

DRAWING LAST PLOTTED ON:
DATE: 08/20/04
SCALE: AS NOTED

SHEET TITLE
DA INSTITUTE OF TECH
CEETHERM DATA LAB
MECHANICAL
PIPING PLAN

PROJECT NO. 1852-150
DATE 08/20/04
SCALE AS NOTED
SHEET M-101

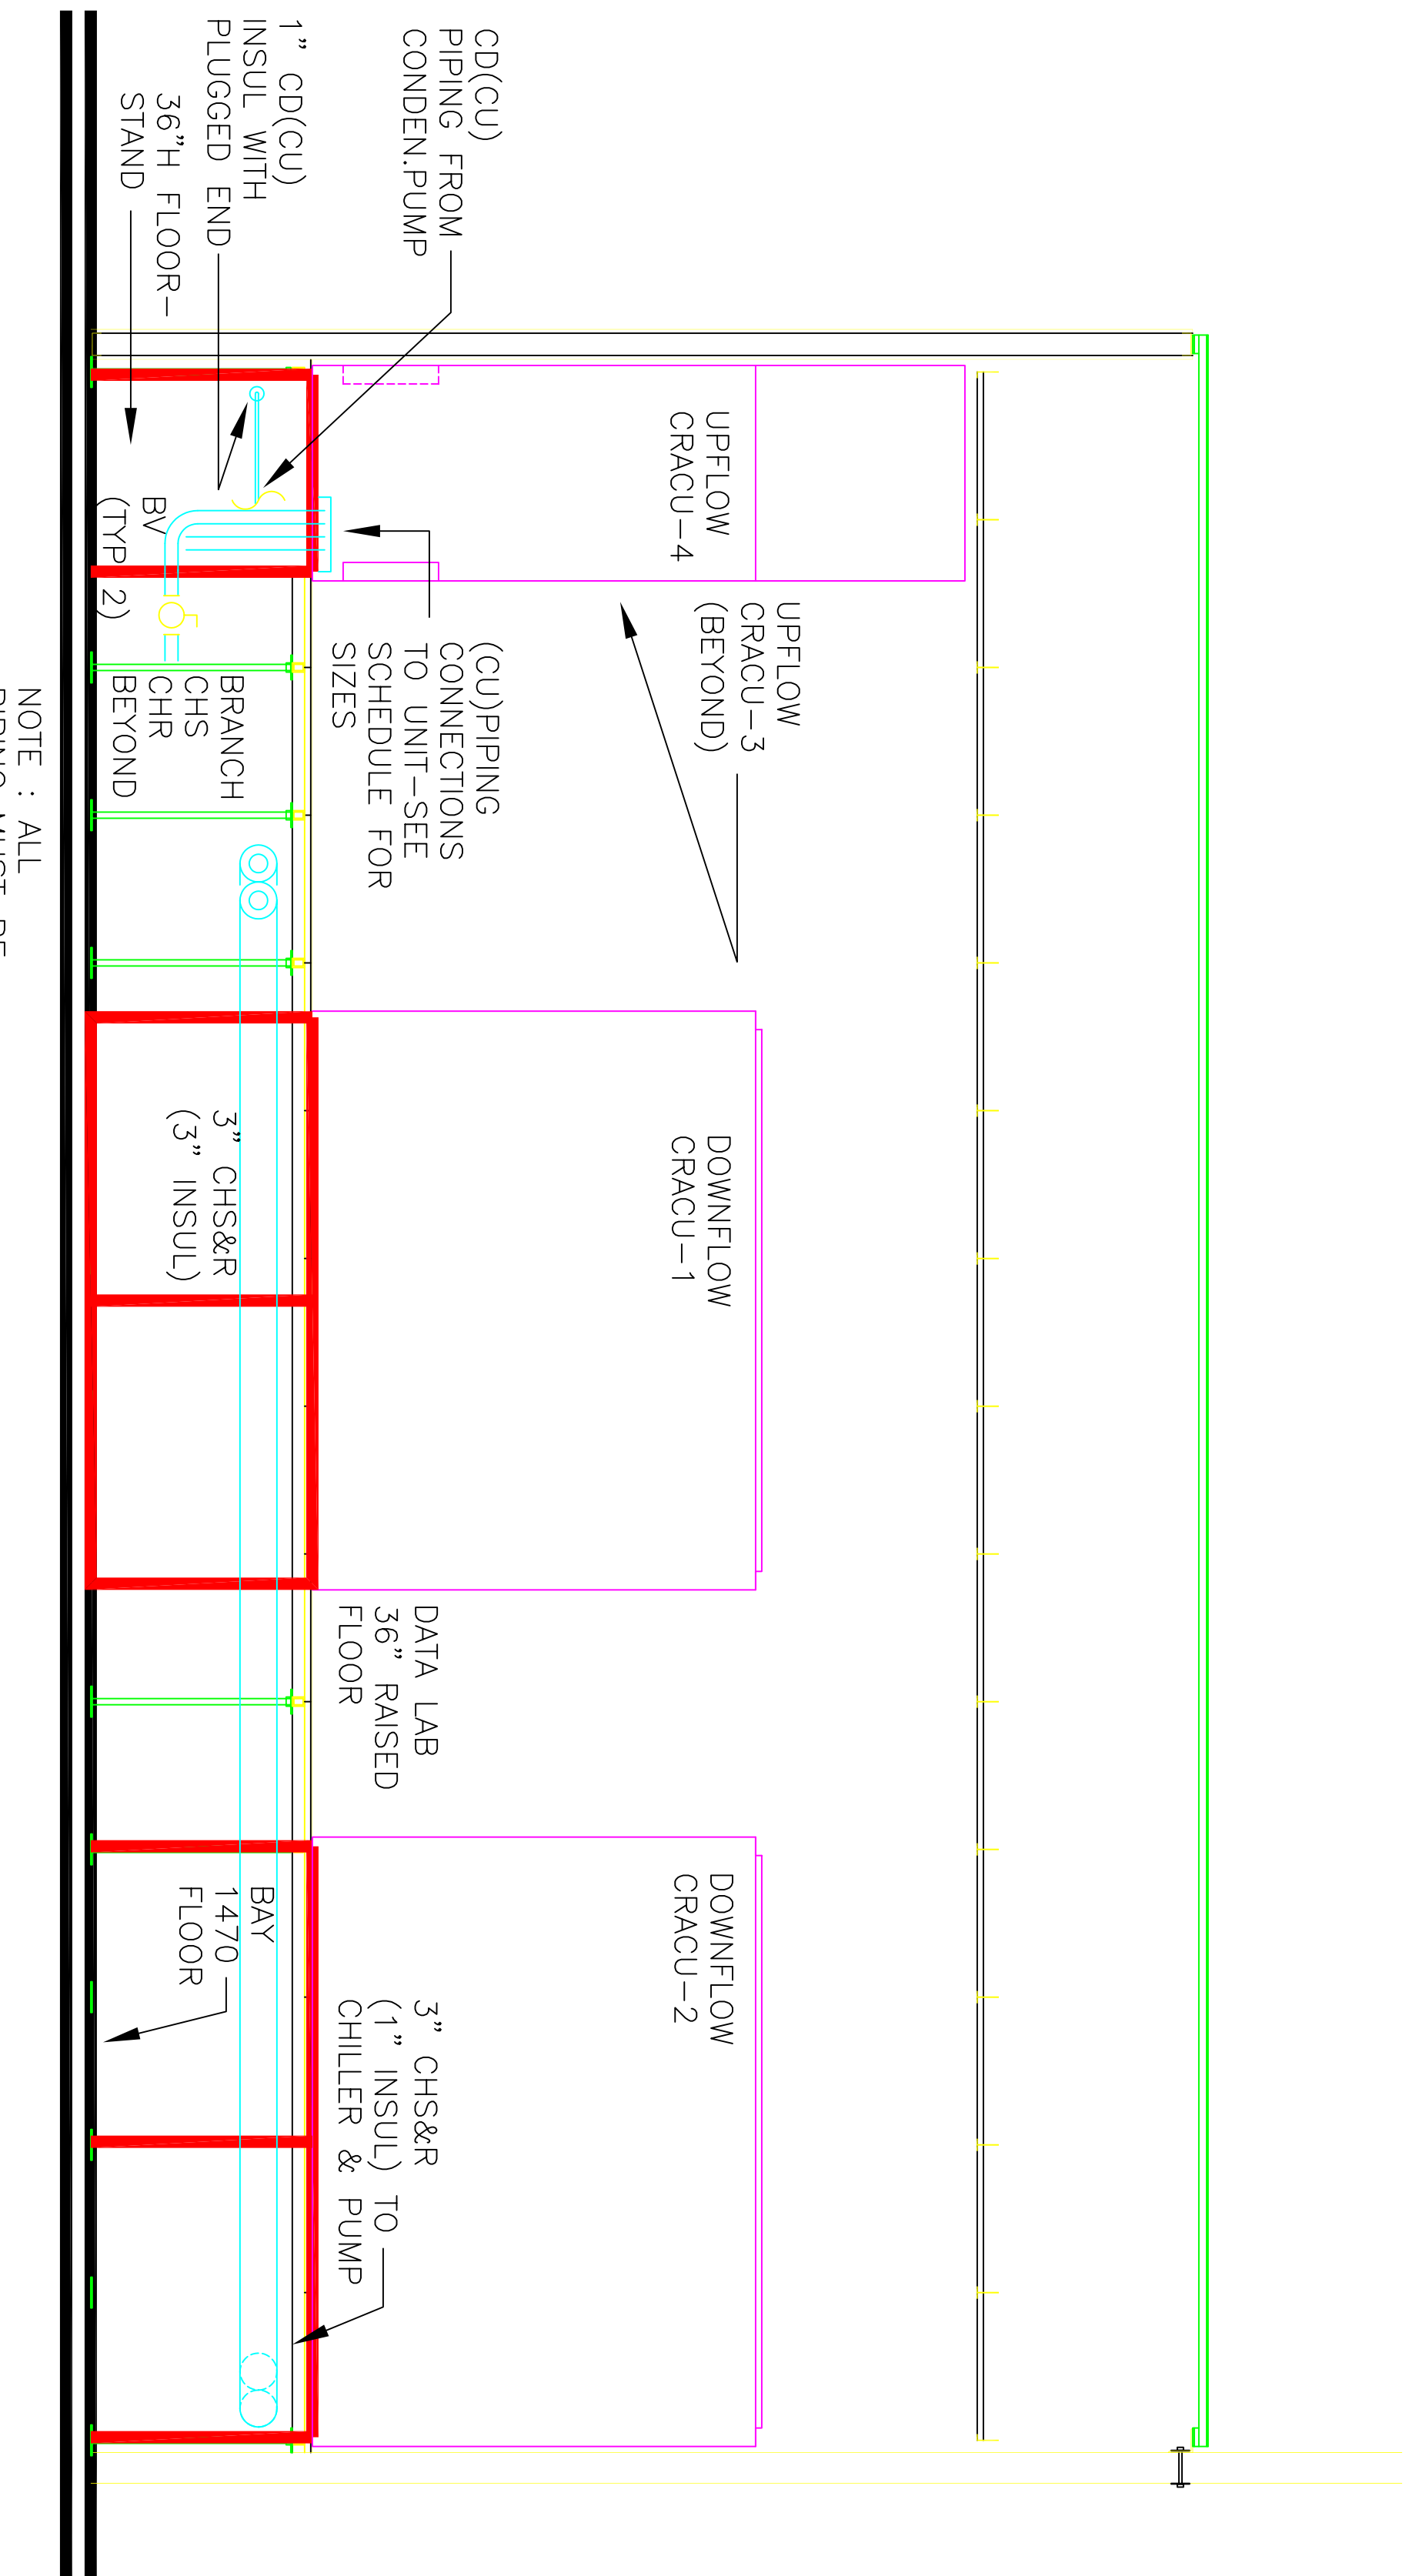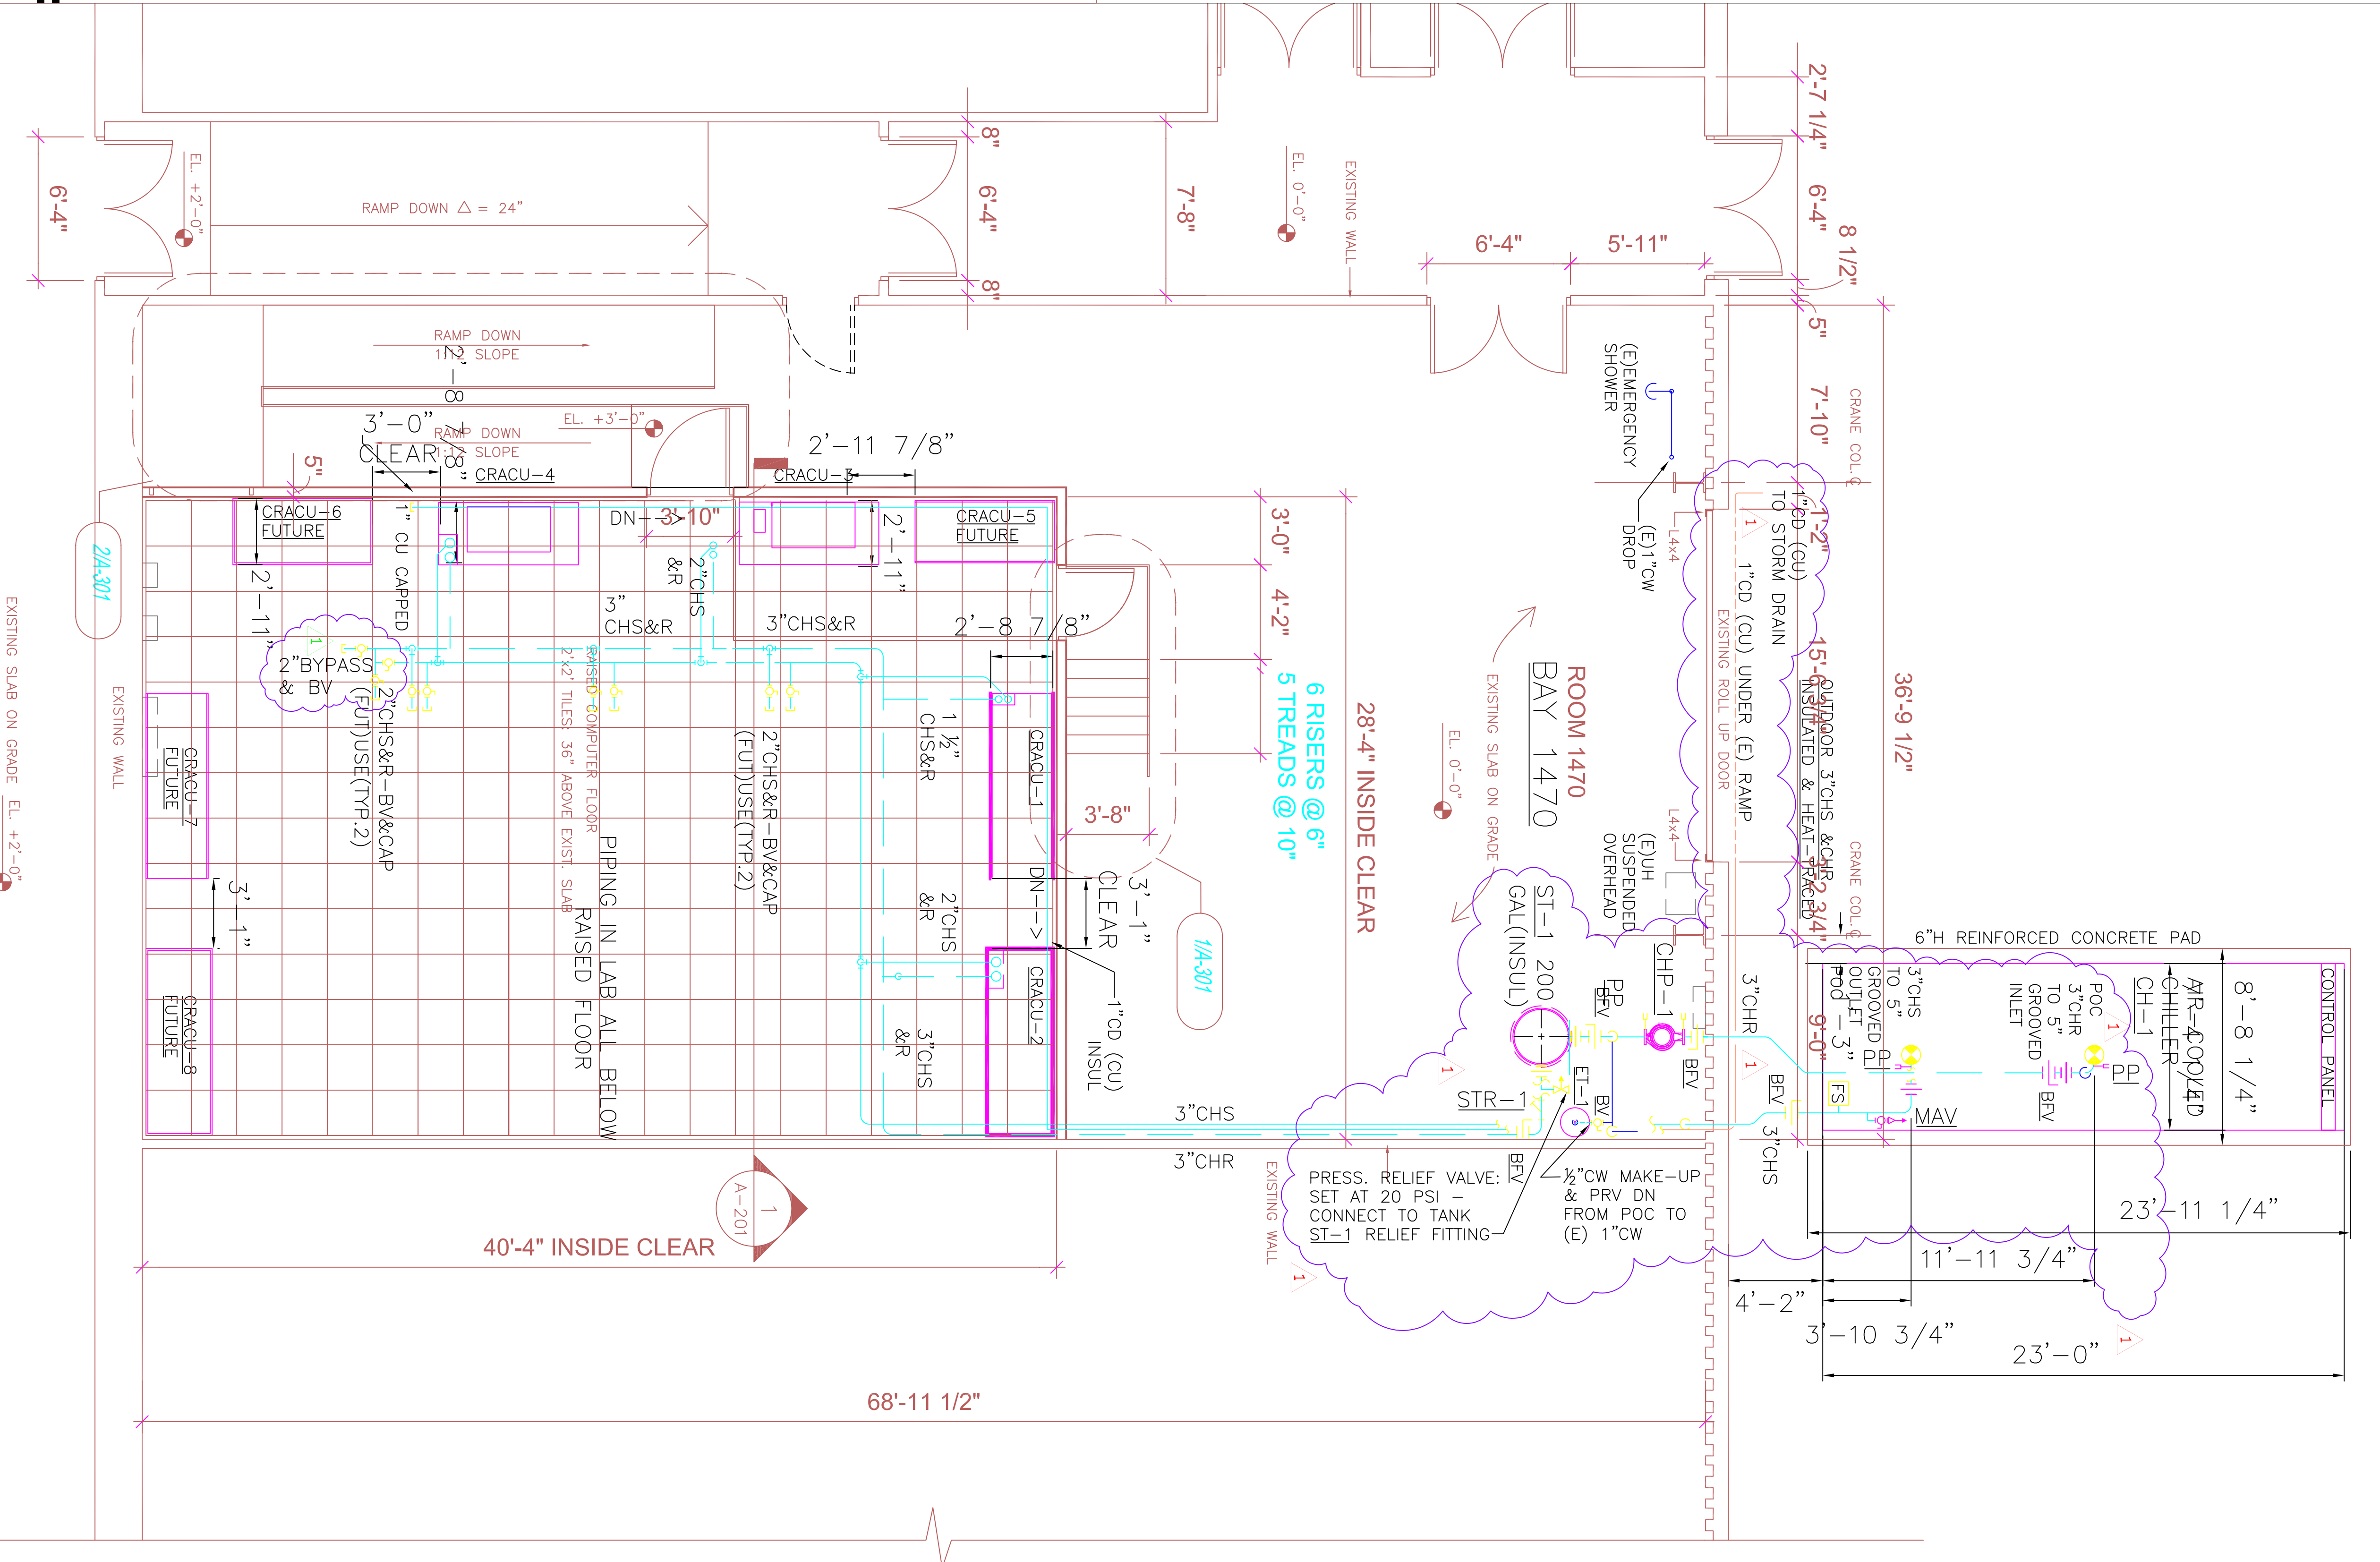

2 CRACU PIPING INSTALLATION
SCALE: 1/2"=1'-0"

1 DATA LAB PIPING PLAN
SCALE: 1/4"=1'-0"