



REFERENCE NOTES:

- ① 75 KVA DRY TYPE TRANSFORMER- SUPPORT FROM T-42, T-82, T-102 AND T-122 TRANSFORMERS FROM TRAPEZE HANGERS 7'-0" HFT.
- ② 300A, 3P, 4W POWER PANEL. SELECT PANEL ENCLOSURES TO MAINTAIN NEC 3"-0" CLEARANCE REQUIREMENT
- ③ NEAR 121-20R RECEPTACLE LOCATED BELOW RAISED FLOOR (TYP)
- ④ CIRCUIT LAYOUT FOR ROW "B" IDENTICAL TO ROW "A", SUBSTITUTE PANEL HOMERUN DESIGNATIONS "1B" AND "2B" FOR "1A" AND "2A" RESPECTIVELY.
- ⑤ CIRCUIT LAYOUT FOR ROW "C" IDENTICAL TO ROW "A", SUBSTITUTE PANEL HOMERUN DESIGNATIONS "1C" AND "2C" FOR "1A" AND "2A" RESPECTIVELY.
- ⑥ CIRCUIT LAYOUT FOR ROW "D" IDENTICAL TO ROW "A", SUBSTITUTE PANEL HOMERUN DESIGNATIONS "1D" AND "2D" FOR "1A" AND "2A" RESPECTIVELY.
- ⑦ EXISTING 480V/277V 200A MCB PANEL "HPGC"
- ⑧ EXISTING 480V/277V 200A MCB PANEL "HPGC"
- ⑨ EXISTING TRANSFORMER AND DISCONNECT TO BE DEMOLISHED AND REMOVED. TURN-OVER TO OWNER.
- ⑩ EXISTING TRANSFORMER AND DISCONNECT TO BE DEMOLISHED AND REMOVED. TURN-OVER TO OWNER.

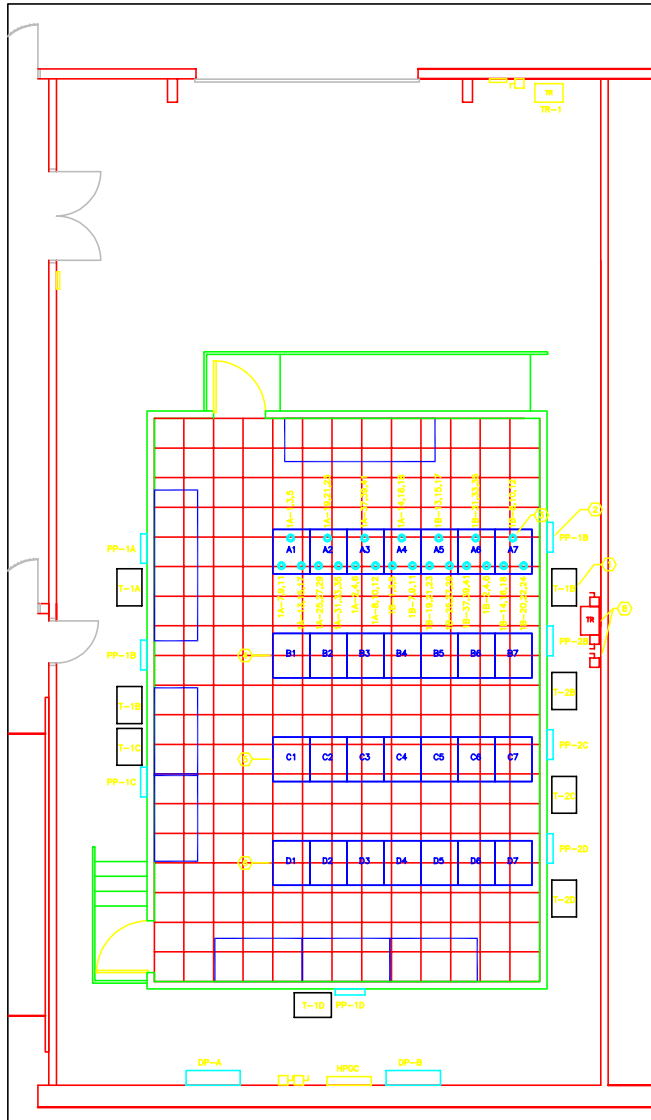

1 POWER PLAN
SCALE: 1/4" = 1'-0"

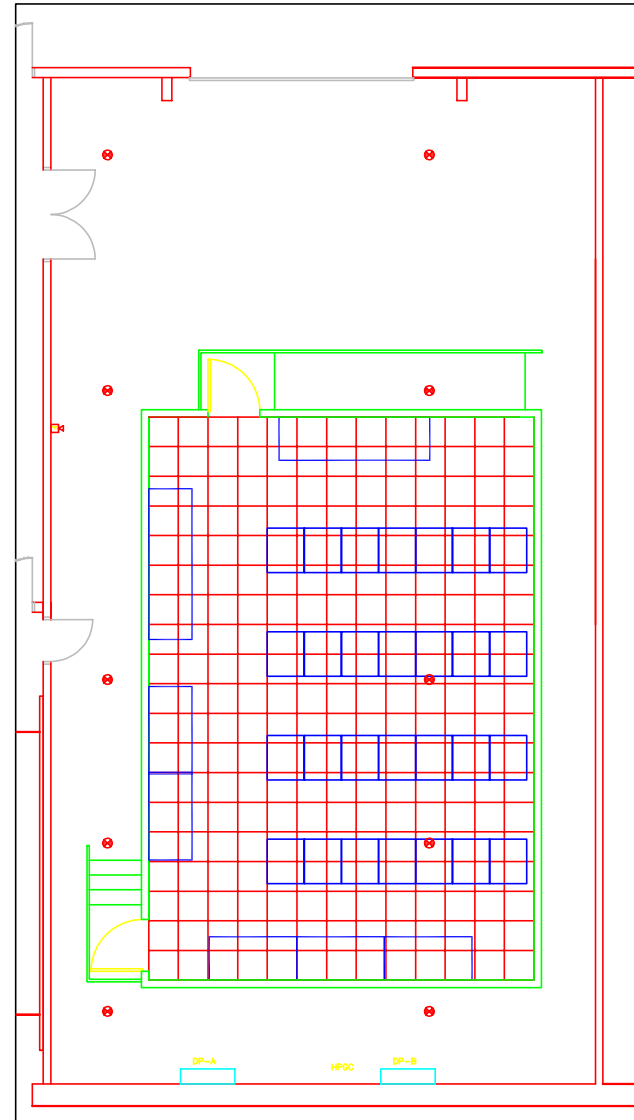

2 SPECIAL SYSTEMS PLAN
SCALE: 1/4" = 1'-0"

DO NOT SCALE DRAWING. CONTRACTOR MUST VERIFY ALL DIMENSIONS AND OTHER CONDITIONS OF ANY EXISTING OR EXISTING. NO VARIATIONS OR MODIFICATIONS TO SHOW FROM SHALL BE AFFIRMED WITHOUT PRIOR WRITTEN APPROVAL. ALL PRELIMINARY SKETCHES OF THIS DRAWING ARE SUPERSEDED BY THE LATEST REVISION. ALL OWNERS AND SUBCONTRACTORS SHALL BE THE PROPERTY OF MORRISON HERSFIELD CORPORATION.

7	
6	
5	
4	
3	
2	
1	

0 9.19.03 PRELIMINARY SKETCHES
No. Date Action



RTKL

RTKL ASSOCIATES, INC.
901 SOUTH BOWIE STREET, BALTIMORE, MD 21201-3300
Tel: (410) 537-8000 Fax: (410) 278-2138



1000 MORELAND RD. BLDG., ATLANTA, GA 30316-3299
Tel: (404) 852-5000 Fax: (404) 854-8886



66 PENNINGTON CENTER E., ATLANTA, GA 30308-1600
Tel: (770) 378-3000 Fax: (770) 378-8001

Project: **CEETHERM LAB**
575 14TH STREET
ATLANTA, GEORGIA 30332-0620

Drawing Title:
ENLARGED ELECTRICAL FLOOR PLAN

Scale: 1/4" = 1'-0"	Project No. 01639 CE
Designer: MW	Date: 10/02/03
Drawn By: DP	Checked By: MW
Drawing File:	Client Approval

Issue No.
0
Drawing No.
E-3