


REFERENCE NOTES:

- ① PROVIDE NEW FUSED SWITCH (SQUARE-D "QMS" TYPE) IN EXISTING 15" SPACE IN SWITCHBOARD MSB1. REFER TO SINGLE LINE DIAGRAM, SHEET E-4 FOR OCP REQUIREMENTS.
- ② ROUTE CONDUITS AT CEILING LEVEL IN MAIN ELECTRICAL ROOM AND AIR HANDLER ROOM, MAINTAIN FIRE RATING OF ALL PENETRATIONS.
- ③ ROUTE CONDUITS ON WALL, MAINTAIN FIRE RATING OF ALL PENETRATIONS.
- ④ TURN CONDUITS DOWN EXTERIOR WALL PENETRATION AND ROUTE UP TO CHILLER SUPPORT JAC OR SAME SUPPORT STRUCTURE INSTALLED FOR CHILLER PIPING.
- ⑤ SUPPORT CONDUITS ON UNSTRUCT FRAME LOCATED ON MEZZANINE OF LAB.

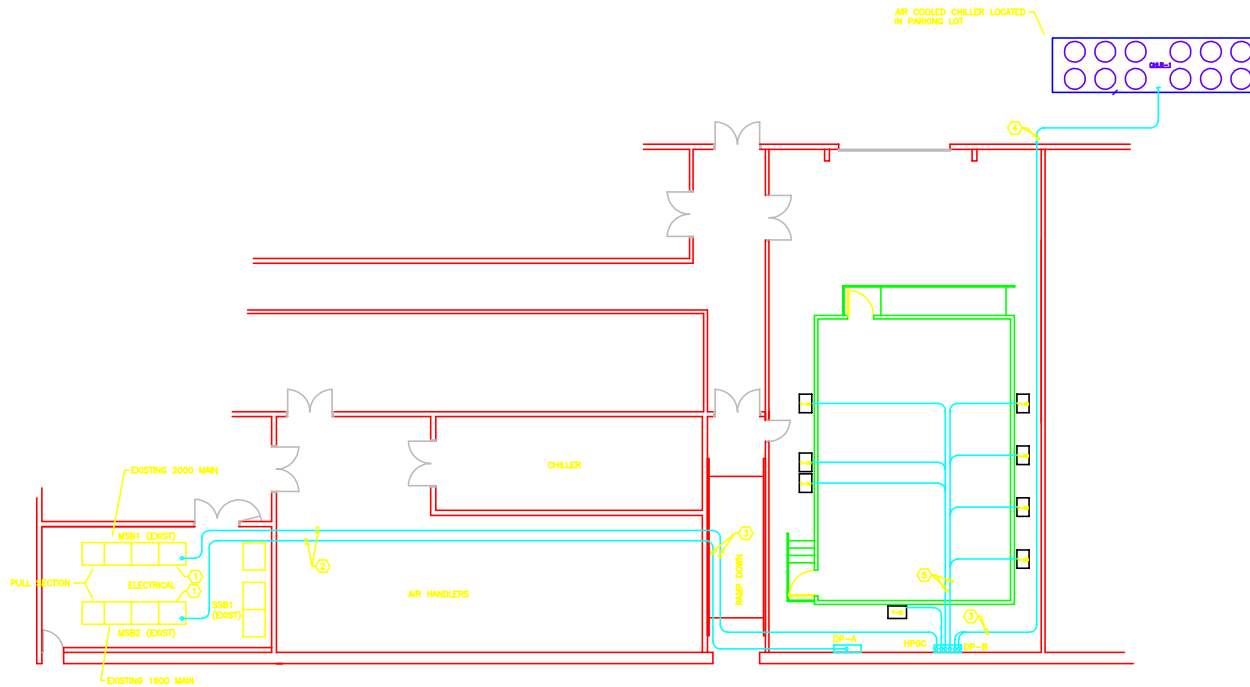

① POWER ROUTING PLAN
SCALE: 1/8" = 1'-0"

DO NOT SCALE DRAWING. CONTRACTOR MUST VERIFY ALL DIMENSIONS AND OTHER CONDITIONS OF ANY EXISTING OR EXPOSURE. NO VARIATIONS OR MODIFICATIONS TO WORK SHALL BE IMPLEMENTED WITHOUT WRITTEN APPROVAL. ALL DIMENSIONS SHALL BE TO THE CENTERLINE UNLESS OTHERWISE SPECIFIED. THIS DRAWING IS THE PROPERTY OF MORRISON HERSHFIELD CORPORATION.

7	
6	
5	
4	
3	
2	
1	
0	9.19.03 PRELIMINARY SKETCHES

No.	Date	Action
0	9.19.03	PRELIMINARY SKETCHES



RTKL
RTKL ASSOCIATES, INC.
901 SOUTH BOWIE STREET, BALTIMORE, MD 21201-3309
Tel: (410) 537-8000 Fax: (410) 278-2138

McKenney's
Mechanical Contractors
1000 MORELAND RD. BLDG. ATLANTA, GA 30316-3299
Tel: (404) 852-0000 Fax: (404) 854-8888

MORRISON HERSHFIELD
66 PERimeter CENTER E, ATLANTA, GA 30346-1600
Tel: (770) 378-3000 Fax: (770) 378-8001

Project: **CEETHERM LAB**
575 14TH STREET
ATLANTA, GEORGIA 30332-0620

Drawing Title:
**PARTIAL FLOOR PLAN
POWER ROUTING**

Scale: 1/8" = 1'-0"	Project No. 01639 CE
Designer: MW	Date: 10/02/03
Drawn By: MW	Checked By: MW
Drawing File:	Client Approval

Issue No.	0
Drawing No.	E-2